

NOTES:-

REFERENCE DRAWING

SR NO. REVISIONS DATE

SHOP DRAWING (SD)

SR NO. REVISIONS DATE

CLIENT:-

BEHZAD ALI AHADPOUR
KHANGHAH

CONSULTANT

AL HILAL
ENGINEERING CONSULTANTS
DUBAI P.O. BOX : 112778
TEL: 3200025, FAX: 3200325
E-mail: info@alhilaengineering.net

MAIN CONTRACTOR

بيت اليازي القاولات
Al-Yazari Contracting
TEL: 04-2697474, FAX: 04-2698727
P.O. BOX: 7579, DUBAI - UAE
E-Mail: info@al-yazari.com

MEP CONTRACTOR:-

MIRK
ELECTROMECHANICAL LLC
P.O. Box 138621, Dubai, UAE
Tel: +971 4 405 8046, Fax: +971 4 405 8048, Email: mirk@mirkgroup.ae

JOB TITLE:-

**PROPOSED COMMERCIAL
AND RESIDENTIAL BUILDING
B+GR+4+ROOF**

PLOT NO:-
JVT07IMRA005



COMMUNITY NAME:-
**AL BARSHA
SOUTH FIFTH**

DRAWING TITLE:-
**TYPICAL FLOOR PLAN
(2nd & 3rd) POWER LAYOUT**

CHECKED BY :- ROWENA DRAWN BY :- TP
SCALE :- 1:125 SHEET SIZE :- A1 DATE :- 01.05.2018


Sheet No. :- SD/EP/004

EP-106

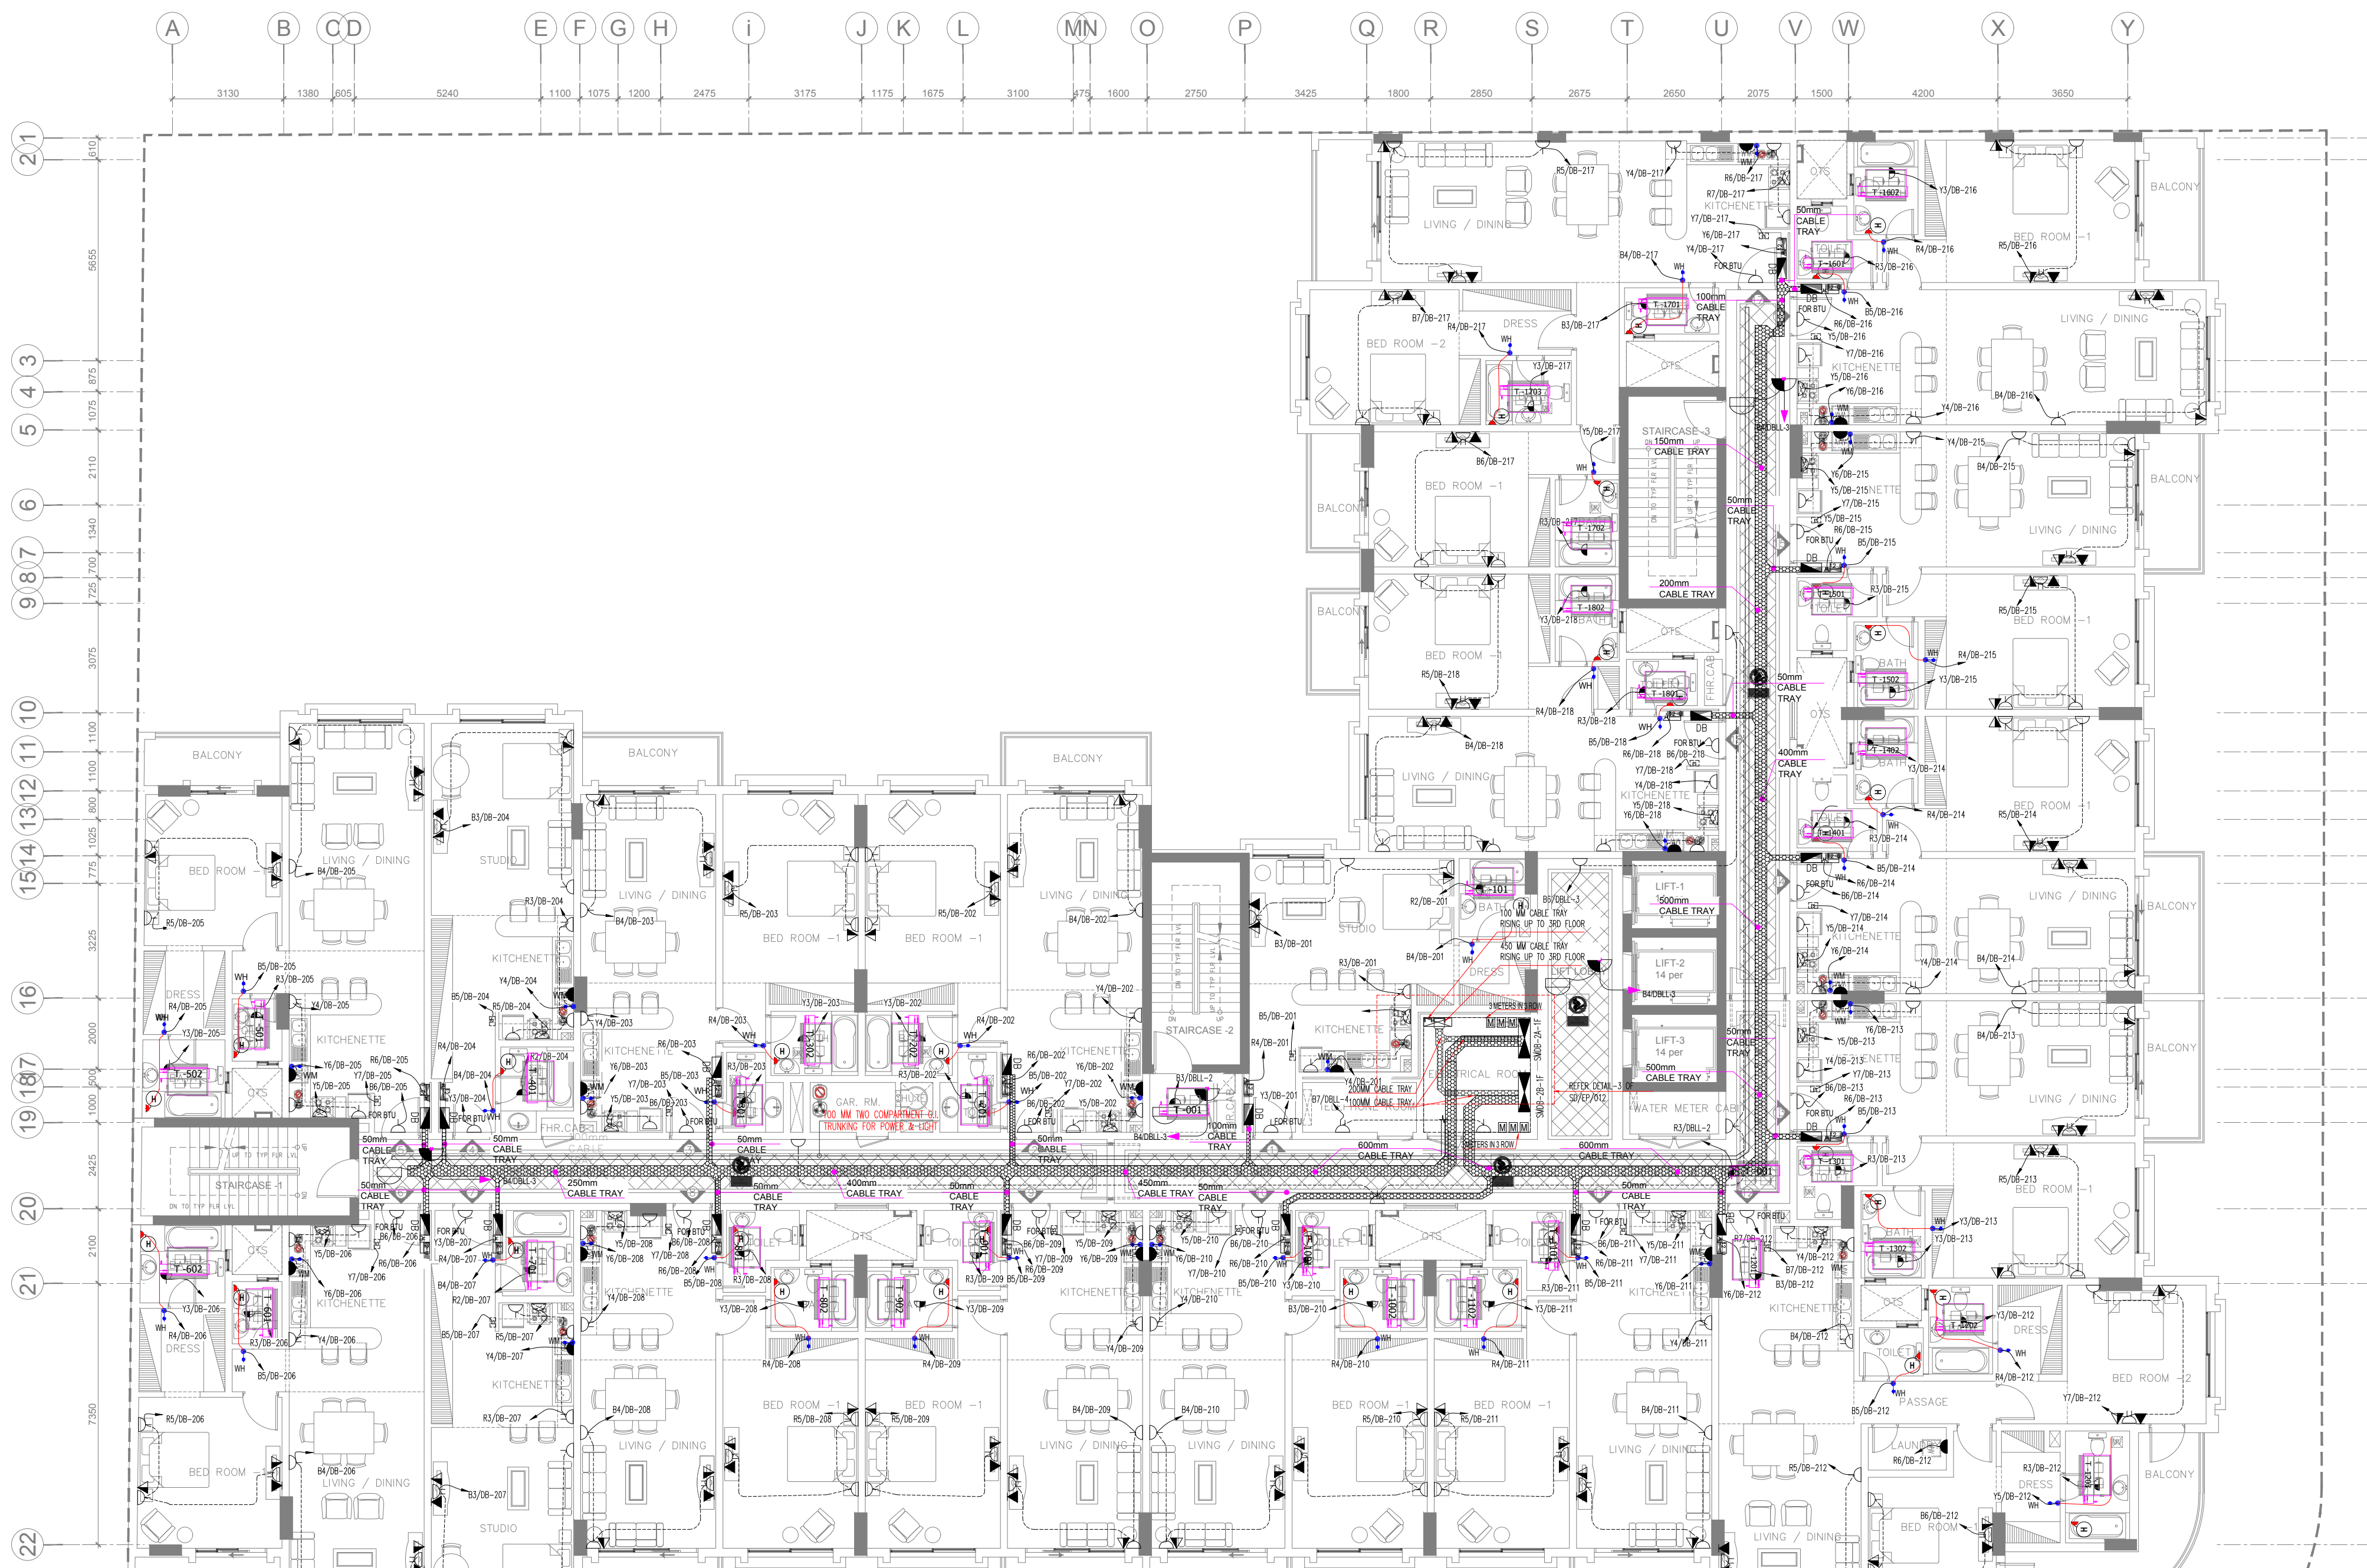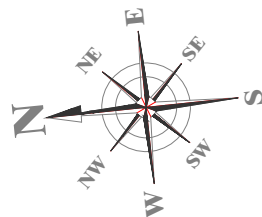

NOTES FOR THE ELECTRICAL SUB CONTRACTOR:

1. CIRCUIT B6/DBL-3 IN SECOND FLOOR - CIRCUIT R7/DBL-4 IN THE THIRD FLOOR.
2. CIRCUIT R3-Y3/DBL-1 IN SECOND FLOOR - CIRCUIT R4-Y4/DBL-2 IN THE THIRD FLOOR.
3. CIRCUIT B4/DBL-3 IN SECOND FLOOR - CIRCUIT B5/DBL-4 IN THE THIRD FLOOR.
4. CIRCUIT B7/DBL-3 IN SECOND FLOOR - CIRCUIT Y7/DBL-4 IN THE THIRD FLOOR.
5. SMOB2A-1F-9KM IN SECOND FLOOR - SMOB-3A-1F KM IN THE THIRD FLOOR.
6. SMOB2B-1F-9KM IN SECOND FLOOR - SMOB-3B-1F KM IN THE THIRD FLOOR.

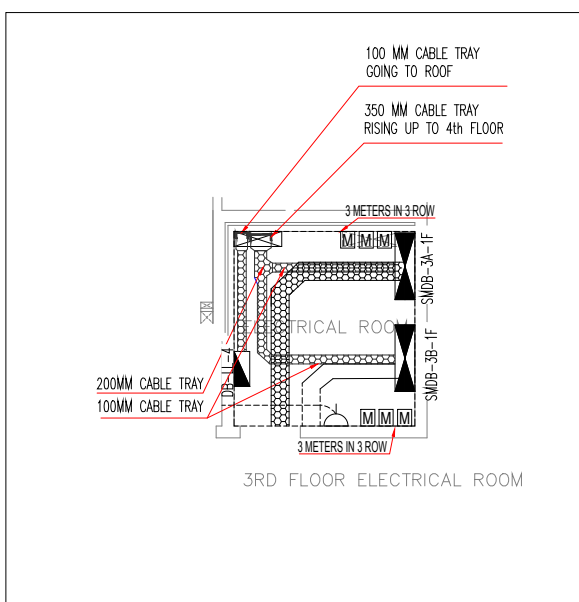

NOTES:

1. ELECTRICAL CONTRACTOR TO CONSIDER & COORDINATE WITH AC DRAWINGS FOR FINAL LOCATION OF FOL ELECTRICAL LOAD DETAILS ETC.
2. ELECTRICAL CONTRACTOR TO CONSIDER ACTUAL AC LOAD FOR DEMA SUBMISSION.
3. CONTRACTOR TO COORDINATE WITH FURNITURE LAYOUT FOR FINAL LOCATION OF ALL THE SOCKETS.
4. CONTRACTOR TO COORDINATE WITH WATER SUPPLY LAYOUT FOR LOCATION OF ALL THE WATER HEATERS.
5. GROUND/FLOOR FLOOR DBs FINAL LOCATION CONTRACTOR TO BE COORDINATED WITH CLIENT - (Before Install).
6. CONTRACTOR TO COORDINATE WITH KITCHEN EQUIPMENT LAYOUT FOR FINAL LOCATION OF - KITCHEN SOCKETS.
7. THE CONTRACTOR SHOULD NOT START ANY ELECTRICAL WORK TILL THE WORKSHOP DRAWINGS ARE APPROVED BY THE CONSULTANT.