

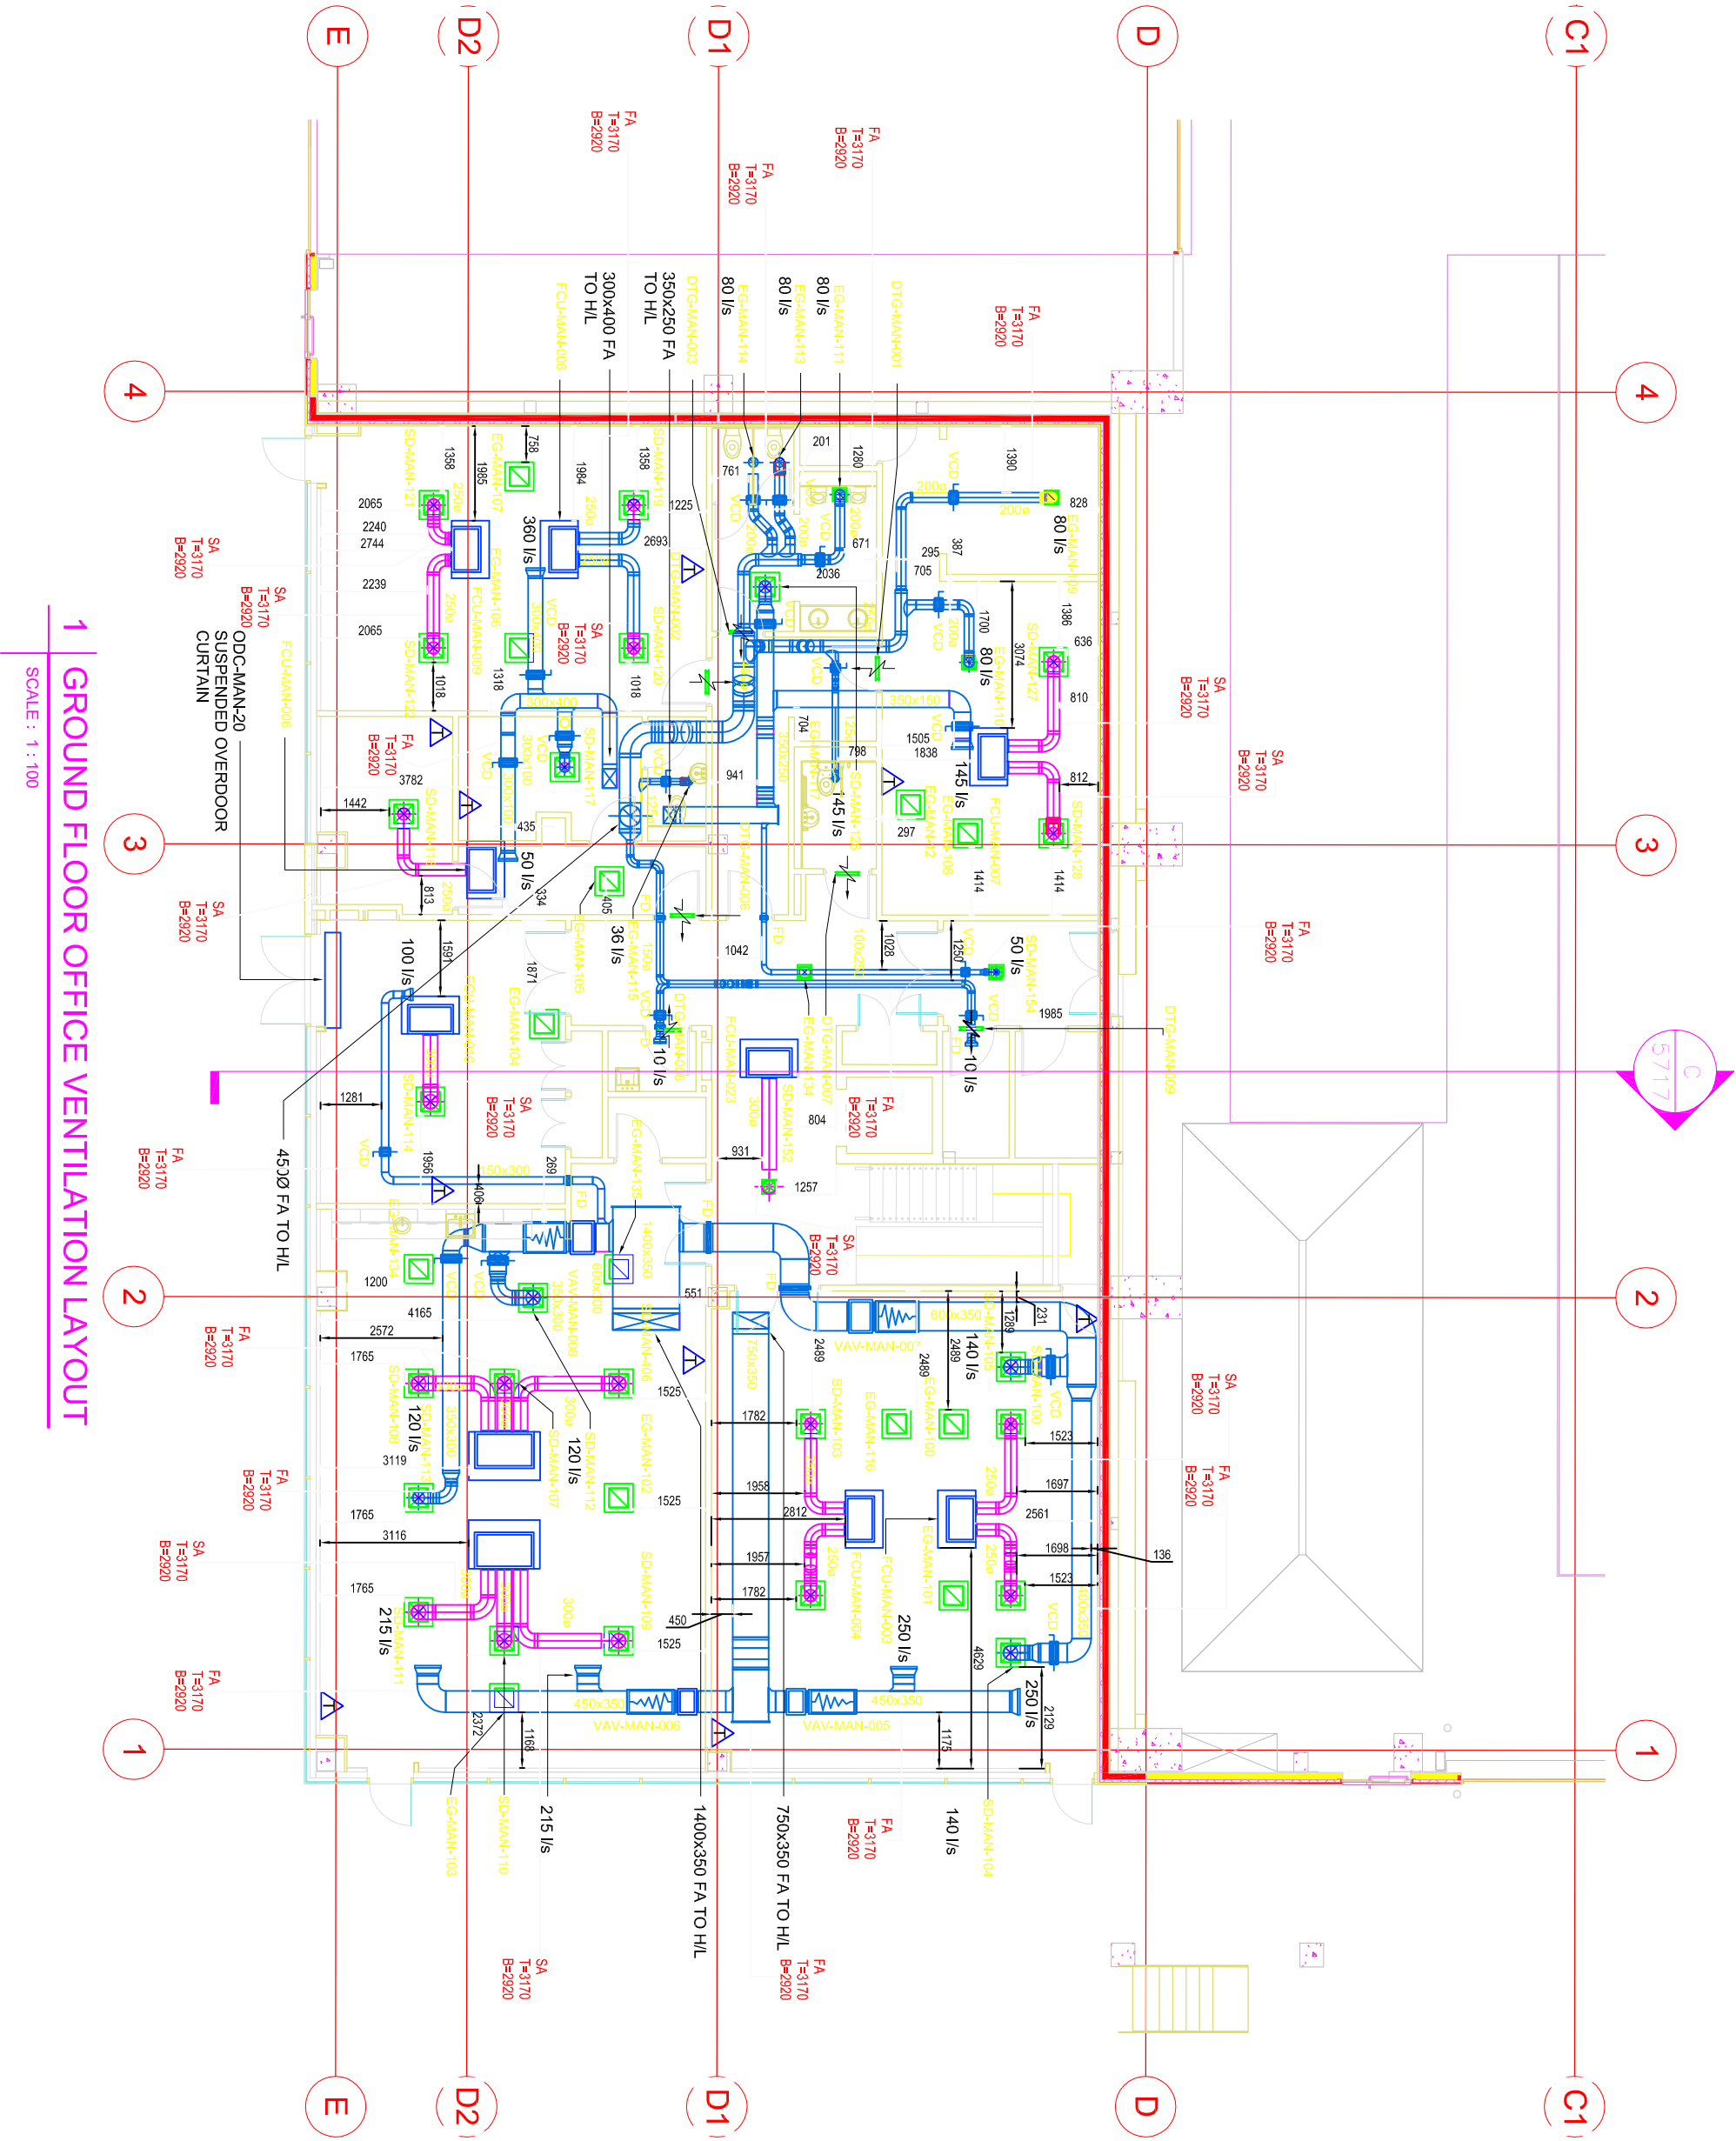


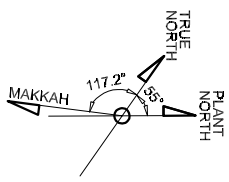


1 | GROUND FLOOR OFFICE VENTILATION LAYOUT

SCALE : 1 : 100

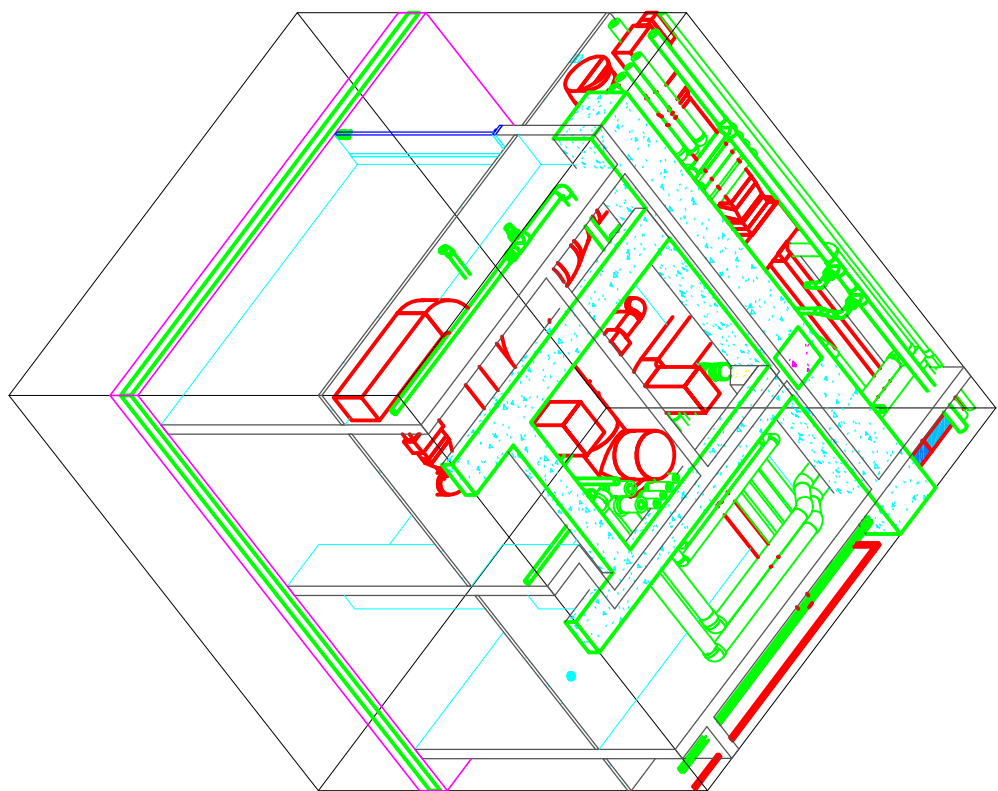

3 | 3D VIEW: RISER DETAIL

SCALE : N.T.S.

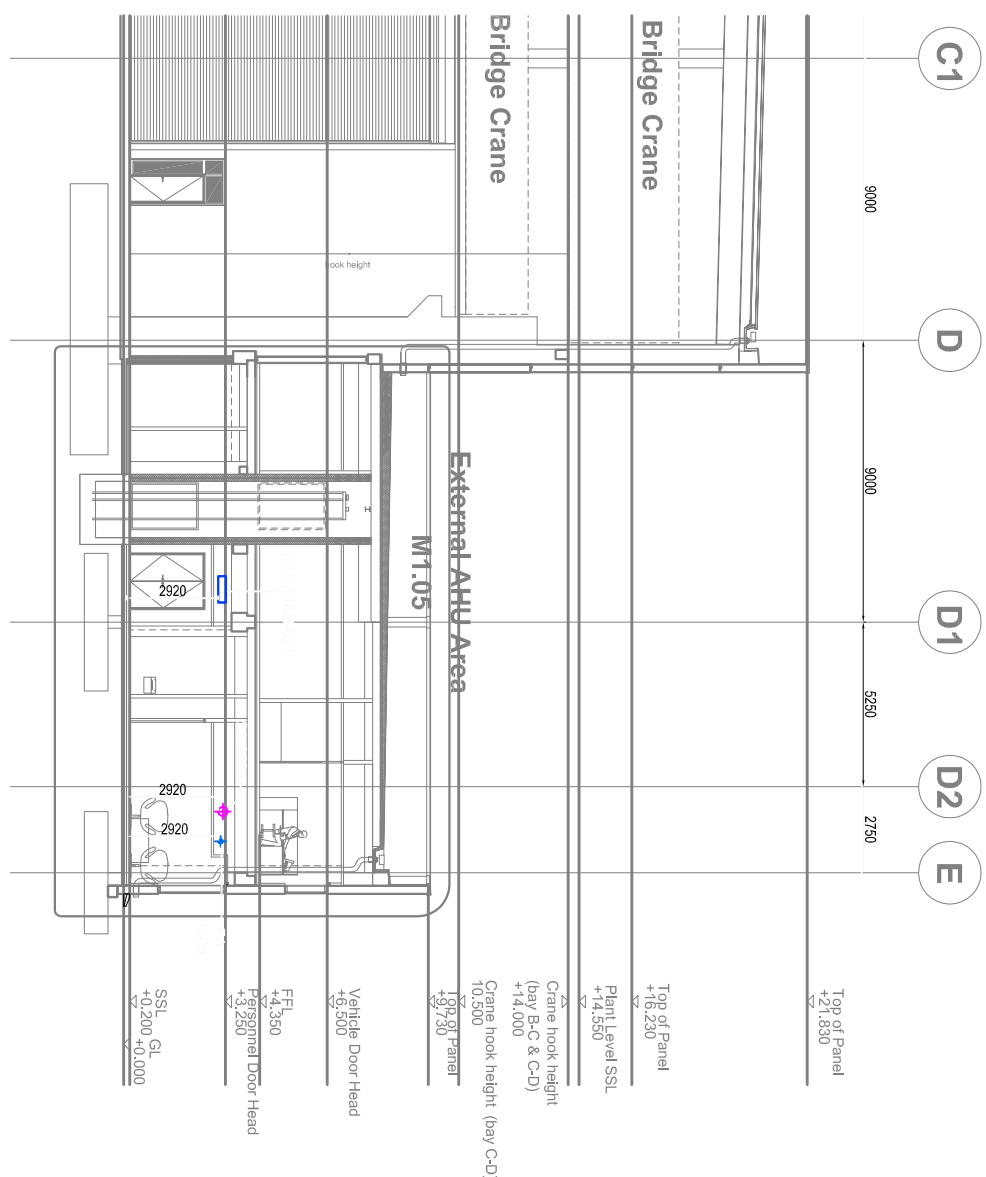

2 | SECTION C

SCALE : 1 : 175