

Marlboro Hall
Renovation and
Addition

Prince George's
Community College
301 Largo Rd, Largo, MD
20774

JCJARCHITECTURE
ONE STATE STREET
SUITE 900
BOSTON, MA 02109
617.532.6600

© 2017 Weigand Associates, Inc.

- CONSULTANTS:
- Civil/ Geotech:
Triad Engineering
1075-D Sherman Avenue
Hagerstown, MD 21740
T: 301.797.6400 F: 301.797.2424
- Envelope:
Coleman Consulting
205 South Tyrone Road
Baltimore, Maryland 21212
T: 410.678.6566 F:
- Hazmat:
Aerosol Monitoring & Analysis
1331 Ashton Road, Suite A
Hanover, Maryland 21076
T: 410.684.3327 F:
- LANDSCAPE:
Flora Teeter Landscape Architects
800 N. Charles Street, Suite 300
Baltimore, MD 21201
T: 410.528.8395 F:
- LEED:
Doo Consulting
531 Piccadilly Rd.
Towson, MD 21204
T: 443.463.5859 F:
- FIRE PROTECTION
Koffel Associates
8615 Centre Park Drive, Suite 200
Columbia, MD 21045
T: 410.750.2246 F:
- MEP
WAI Weigand Associates, Inc.
20270 Goldenrod Land
Germanstown, MD 20876
T: 301.540.9060 F: 301.540.9061
- STRUCTURAL
Siman Associates Structural Engineers
1053 31st Street NW
Washington, DC 20007
T: 202.333.6230 F:

SD SET

NOT FOR
CONSTRUCTION


PROFESSIONAL CERTIFICATION:
I HEREBY CERTIFY THAT THESE DOCUMENTS WERE
PREPARED OR APPROVED BY ME, AND THAT I AM A DULY
LICENSED PROFESSIONAL ENGINEER UNDER THE LAWS
OF THE STATE OF MARYLAND, LICENSE NO. 17366,
EXPIRATION DATE MAY 29, 2017.

ISSUE 20122017
JOB B.1704700
DRAWN MW
SCALE 1/16" = 1'-0"

REVISIONS:

MECHANICAL
OVERALL PLAN
ROOF LEVEL


ME-104

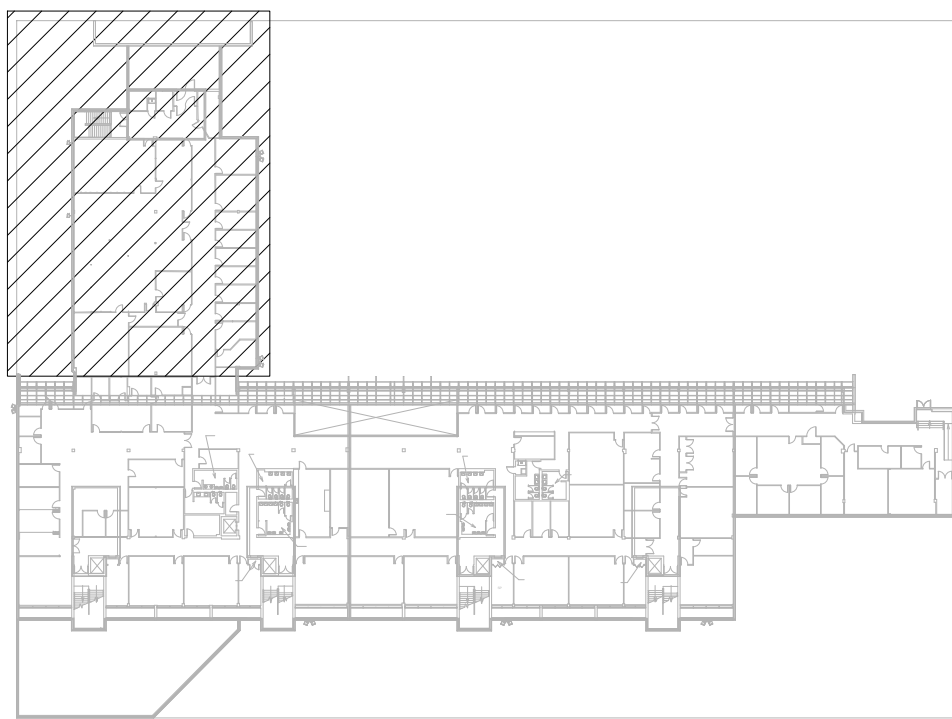

KEY PLAN

KEYED NOTES:

1 ABANDONED HEAT RECOVERY SUPPLY FAN.

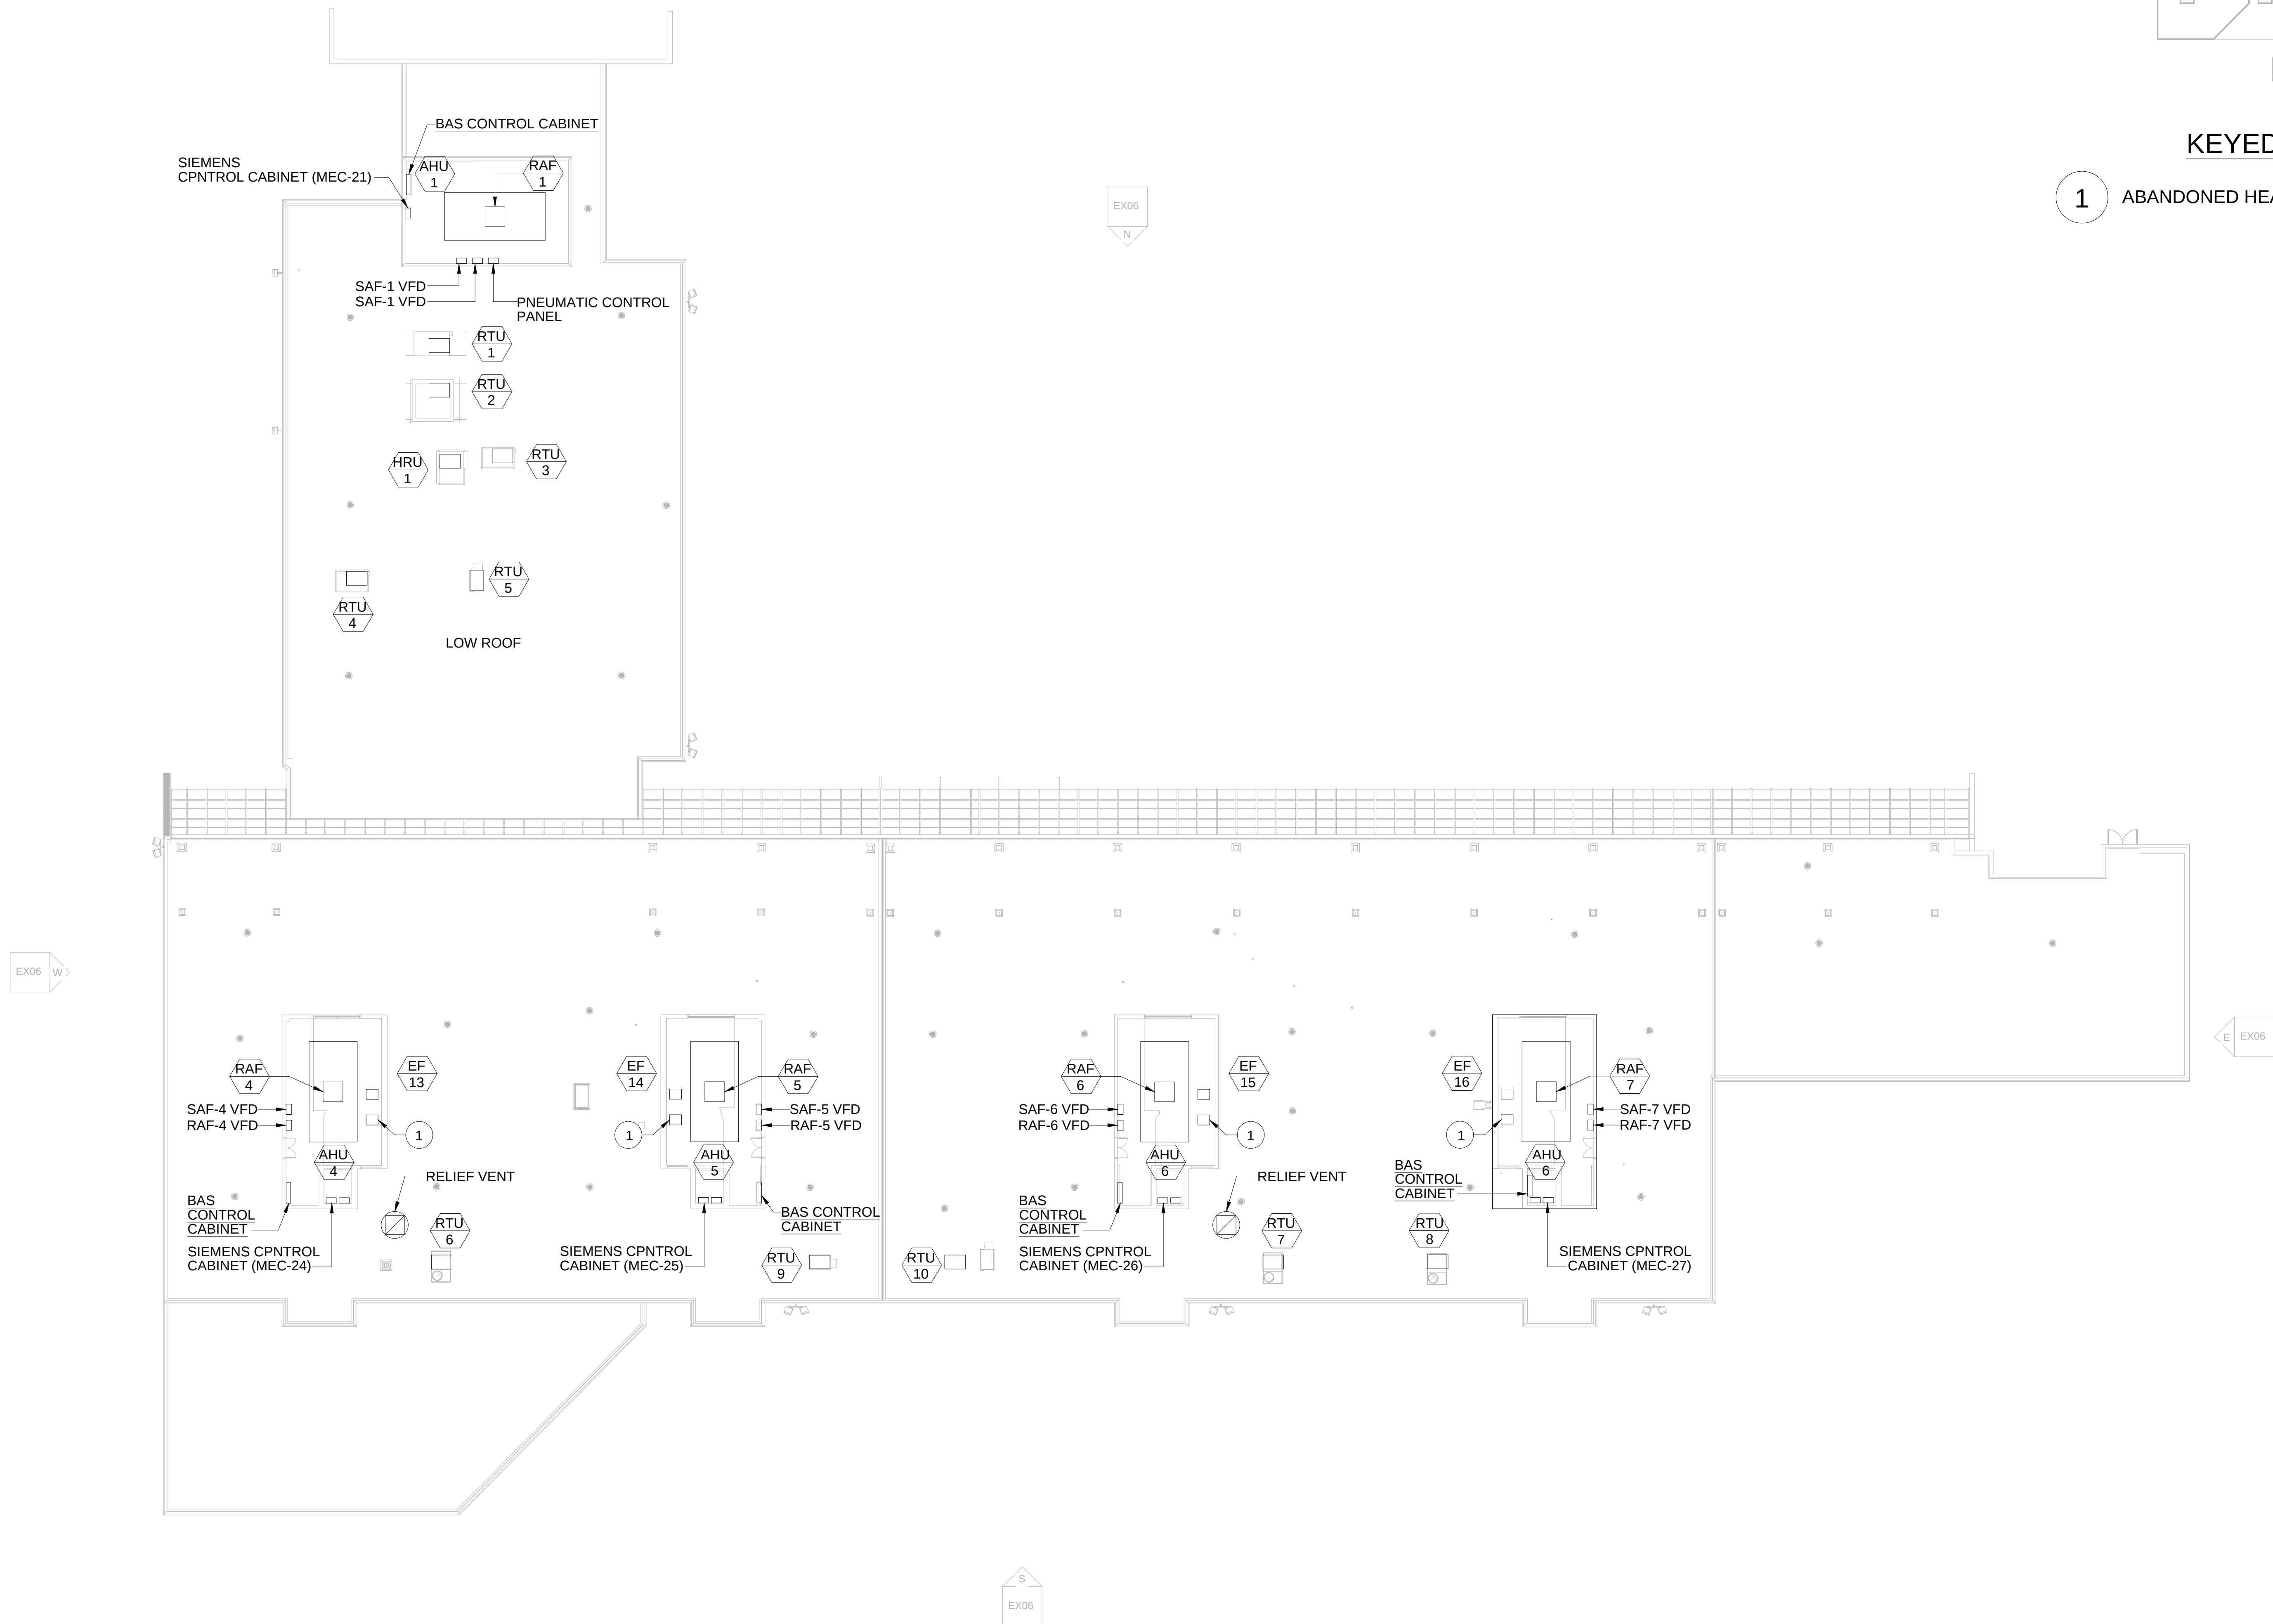

ROOF PLAN -MECHANICAL
SCALE: 1/16" = 1'-0"